




**BOILER ROOM ROOF PLAN**  
Scale 1/4" = 1'-0"

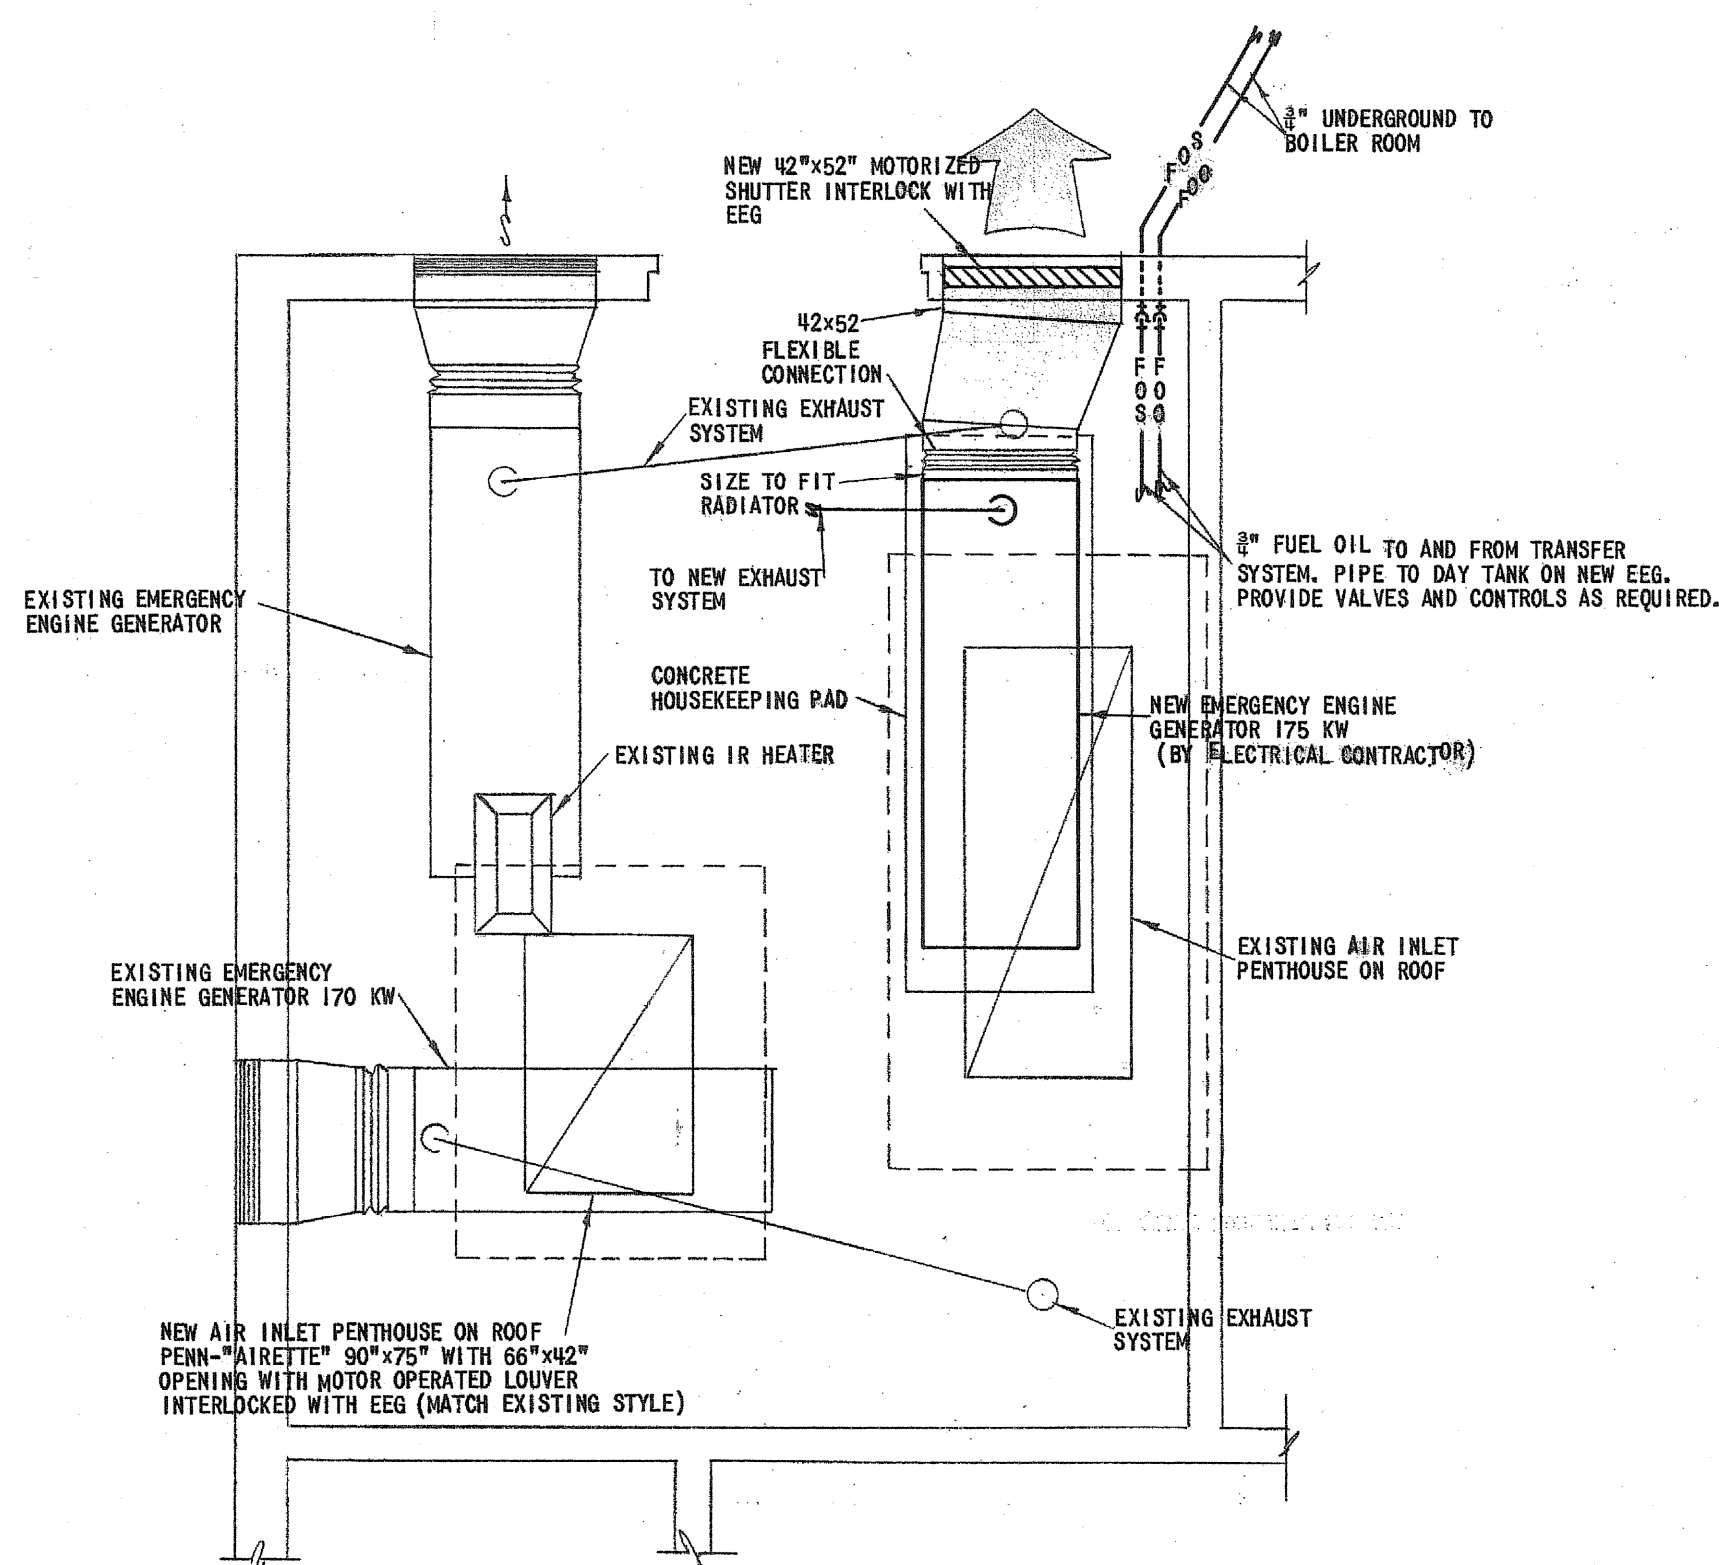


**ENGINE GENERATOR ROOM PARTIAL PLAN**  
Scale 1/4" = 1'-0"

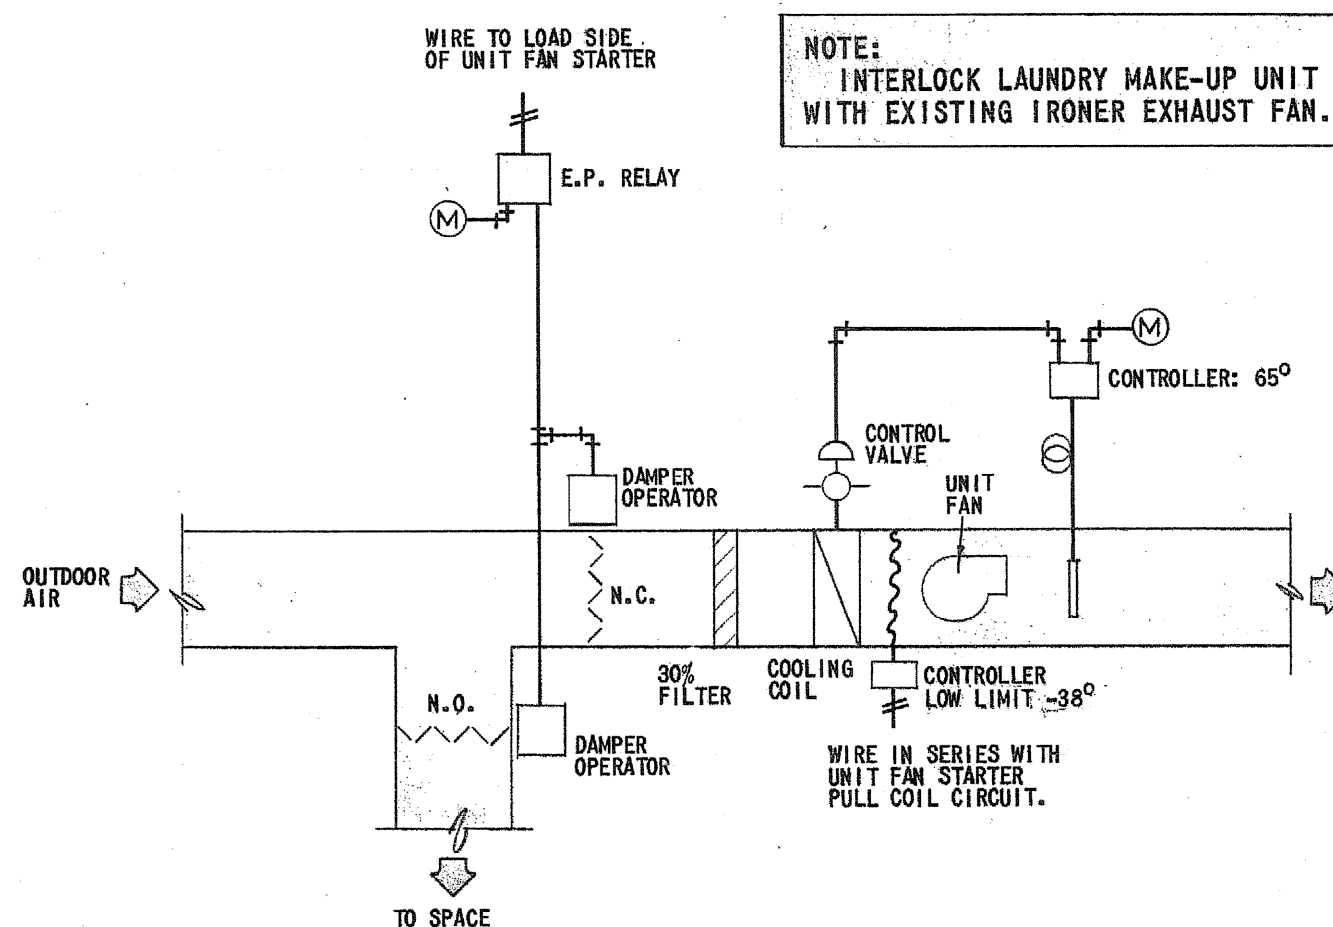

**LAUNDRY MAKE-UP UNIT CONTROLS**  
Scale

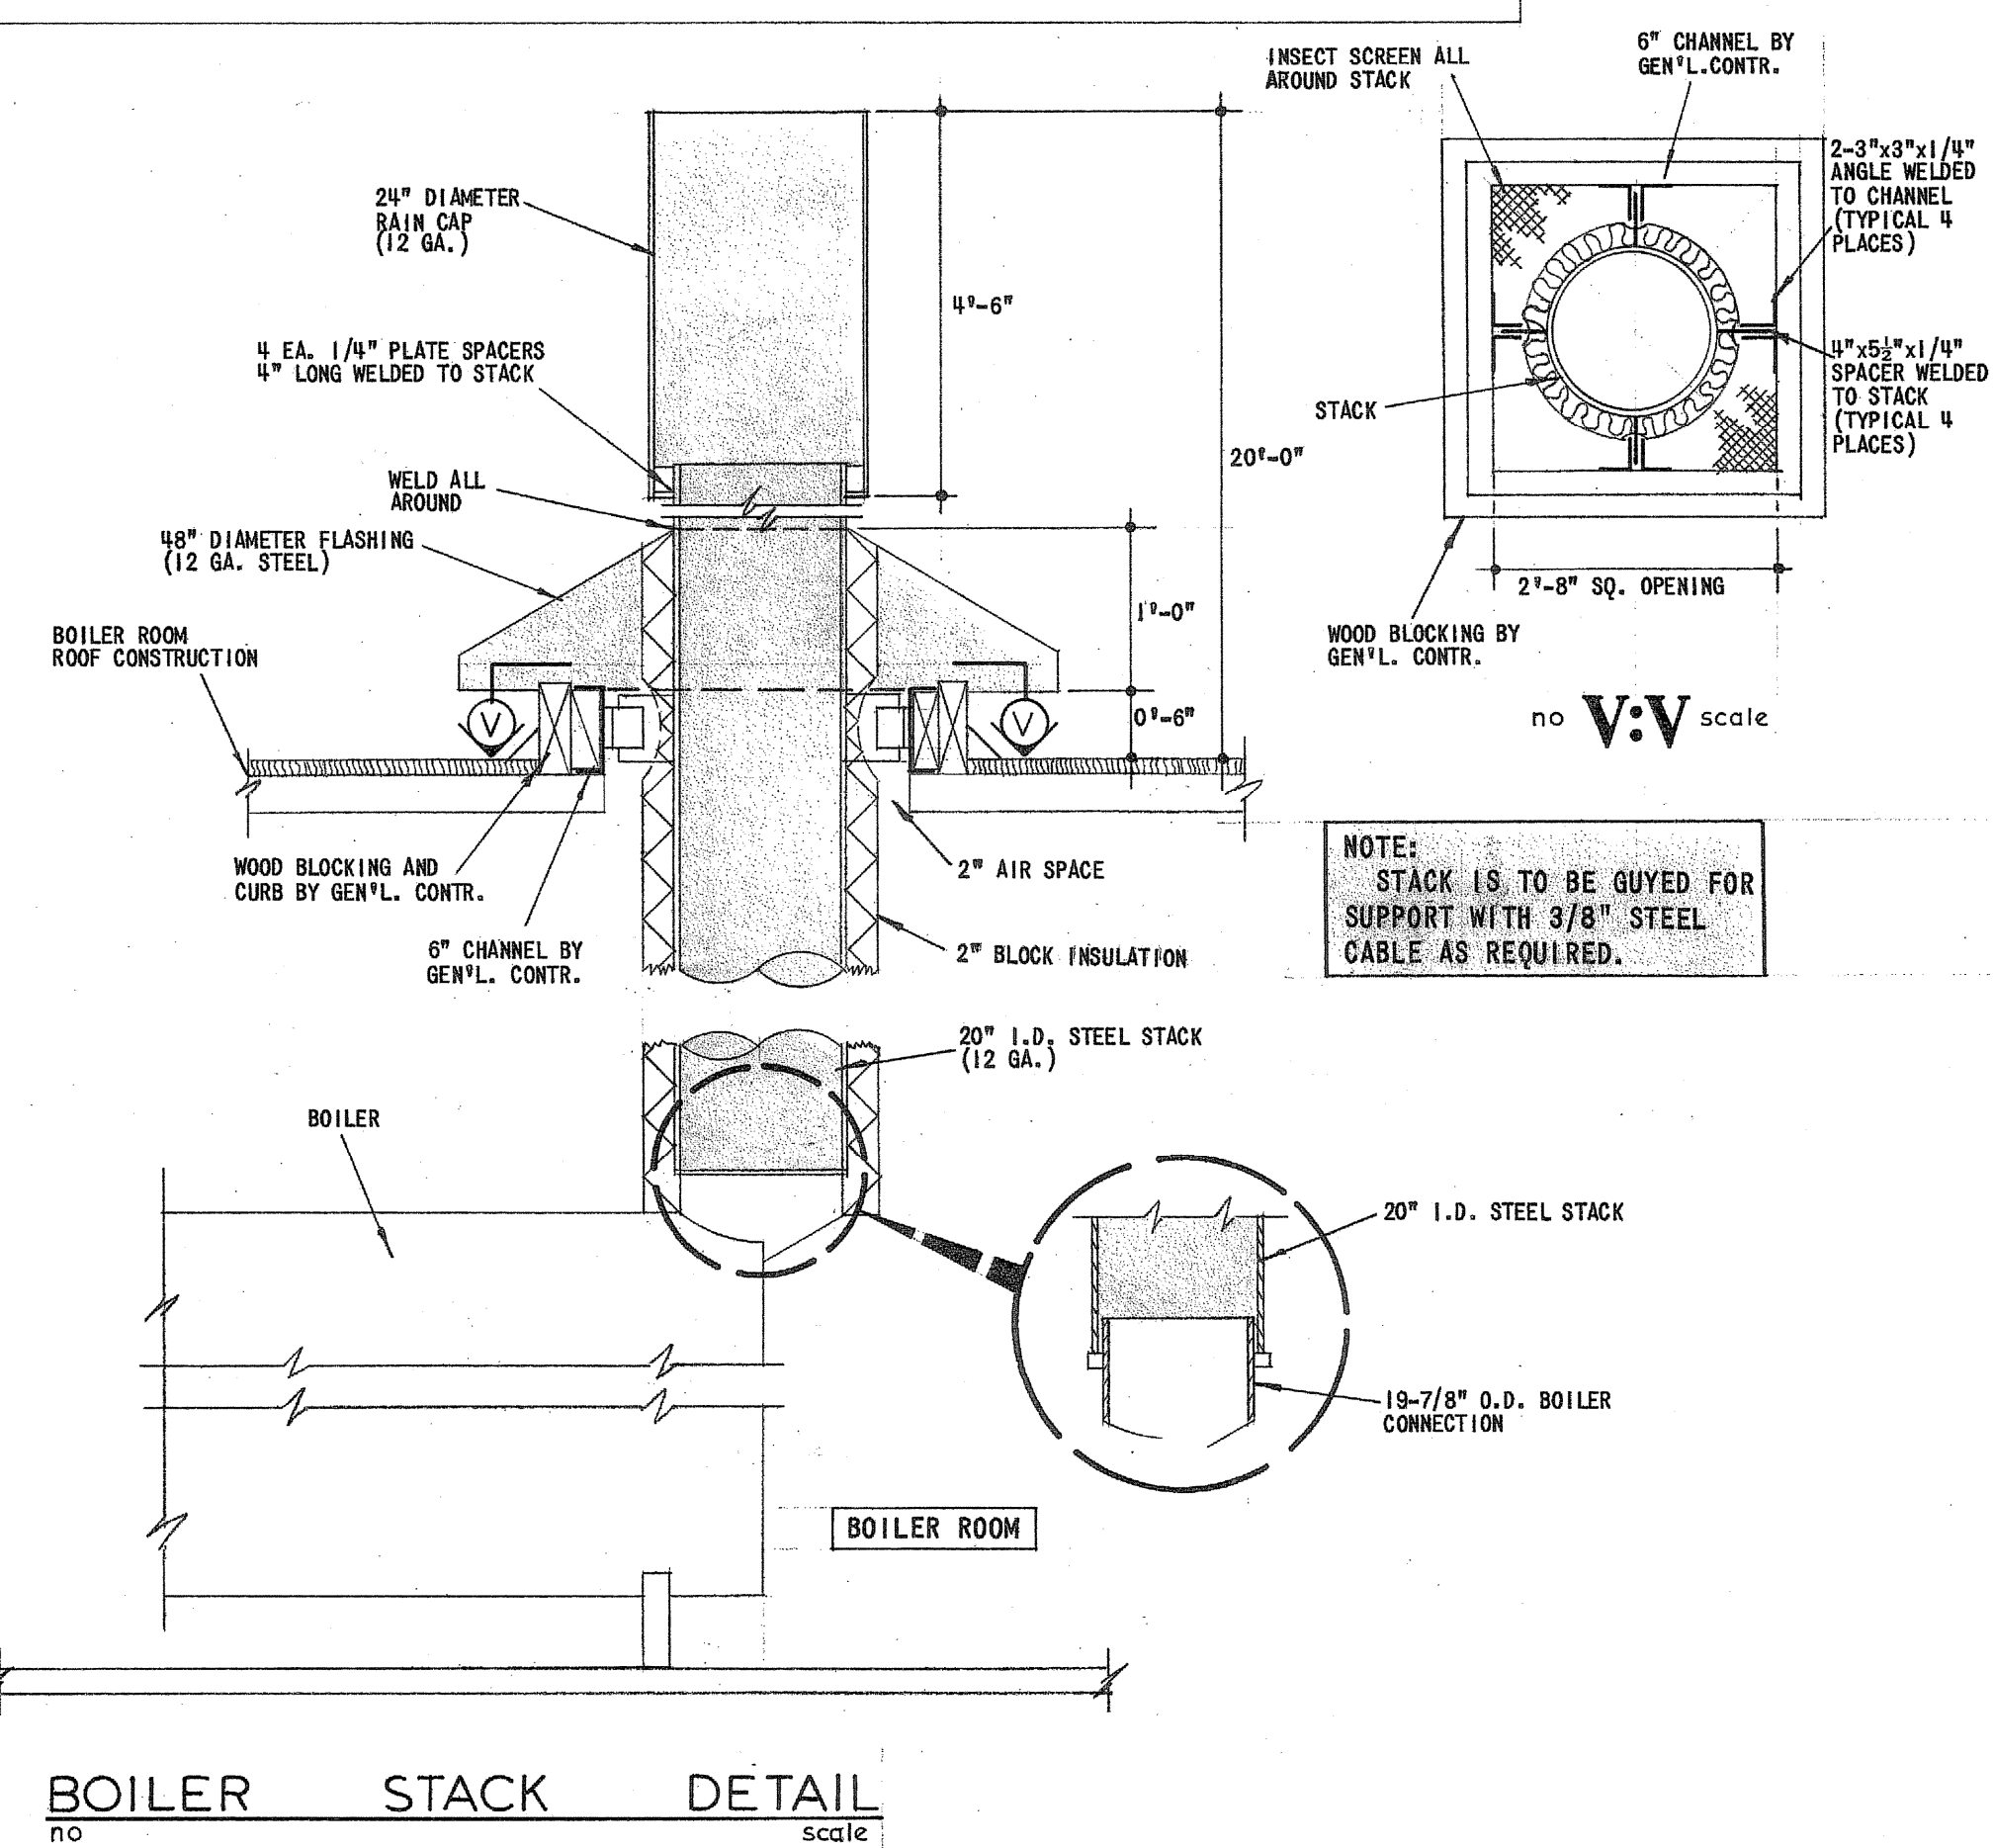

**BOILER STACK DETAIL**  
Scale

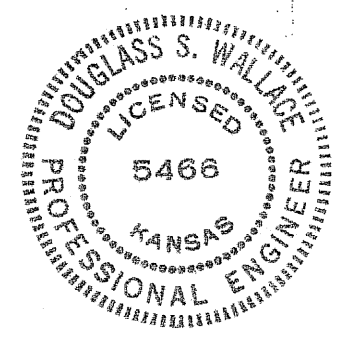

BURGESS, LATIMER & MILLER, P.C.  
2153 CALIFORNIA STREET  
TOPEKA, KANSAS 66605

BOILER ROOM ROOF PLAN - MECHANICAL	
NORTH ADDITION TO ST. CATHERINE HOSPITAL GARDEN CITY KANSAS	
DRAWN BY	BLANCHARD, VANDERWEIDE & FILLMORE
CHECKED BY	ARCHITECTS AIA
JOB NO.	GARDEN CITY KANSAS
SHEET NO. M-10	